

Project Name  
**Security Upgrades and Enhancements at Ewing High School**

Project Owner Name  
**Ewing Public Schools District**


Project Location  
**900 Parkway Avenue, Ewing, NJ 08618**

Project Number  
**5288A**  
 Project Date  
**06.06.2022**  
 Checked By  
**AHG**  
 Drawn By  
**AMP**  
 Scale  
**AS SHOWN**

Drawing Name  
**ELECTRICAL PLANNING BOARD SITE PLAN**


Revisions		
No.	Date	Description

Drawing Number  
**SU-1**

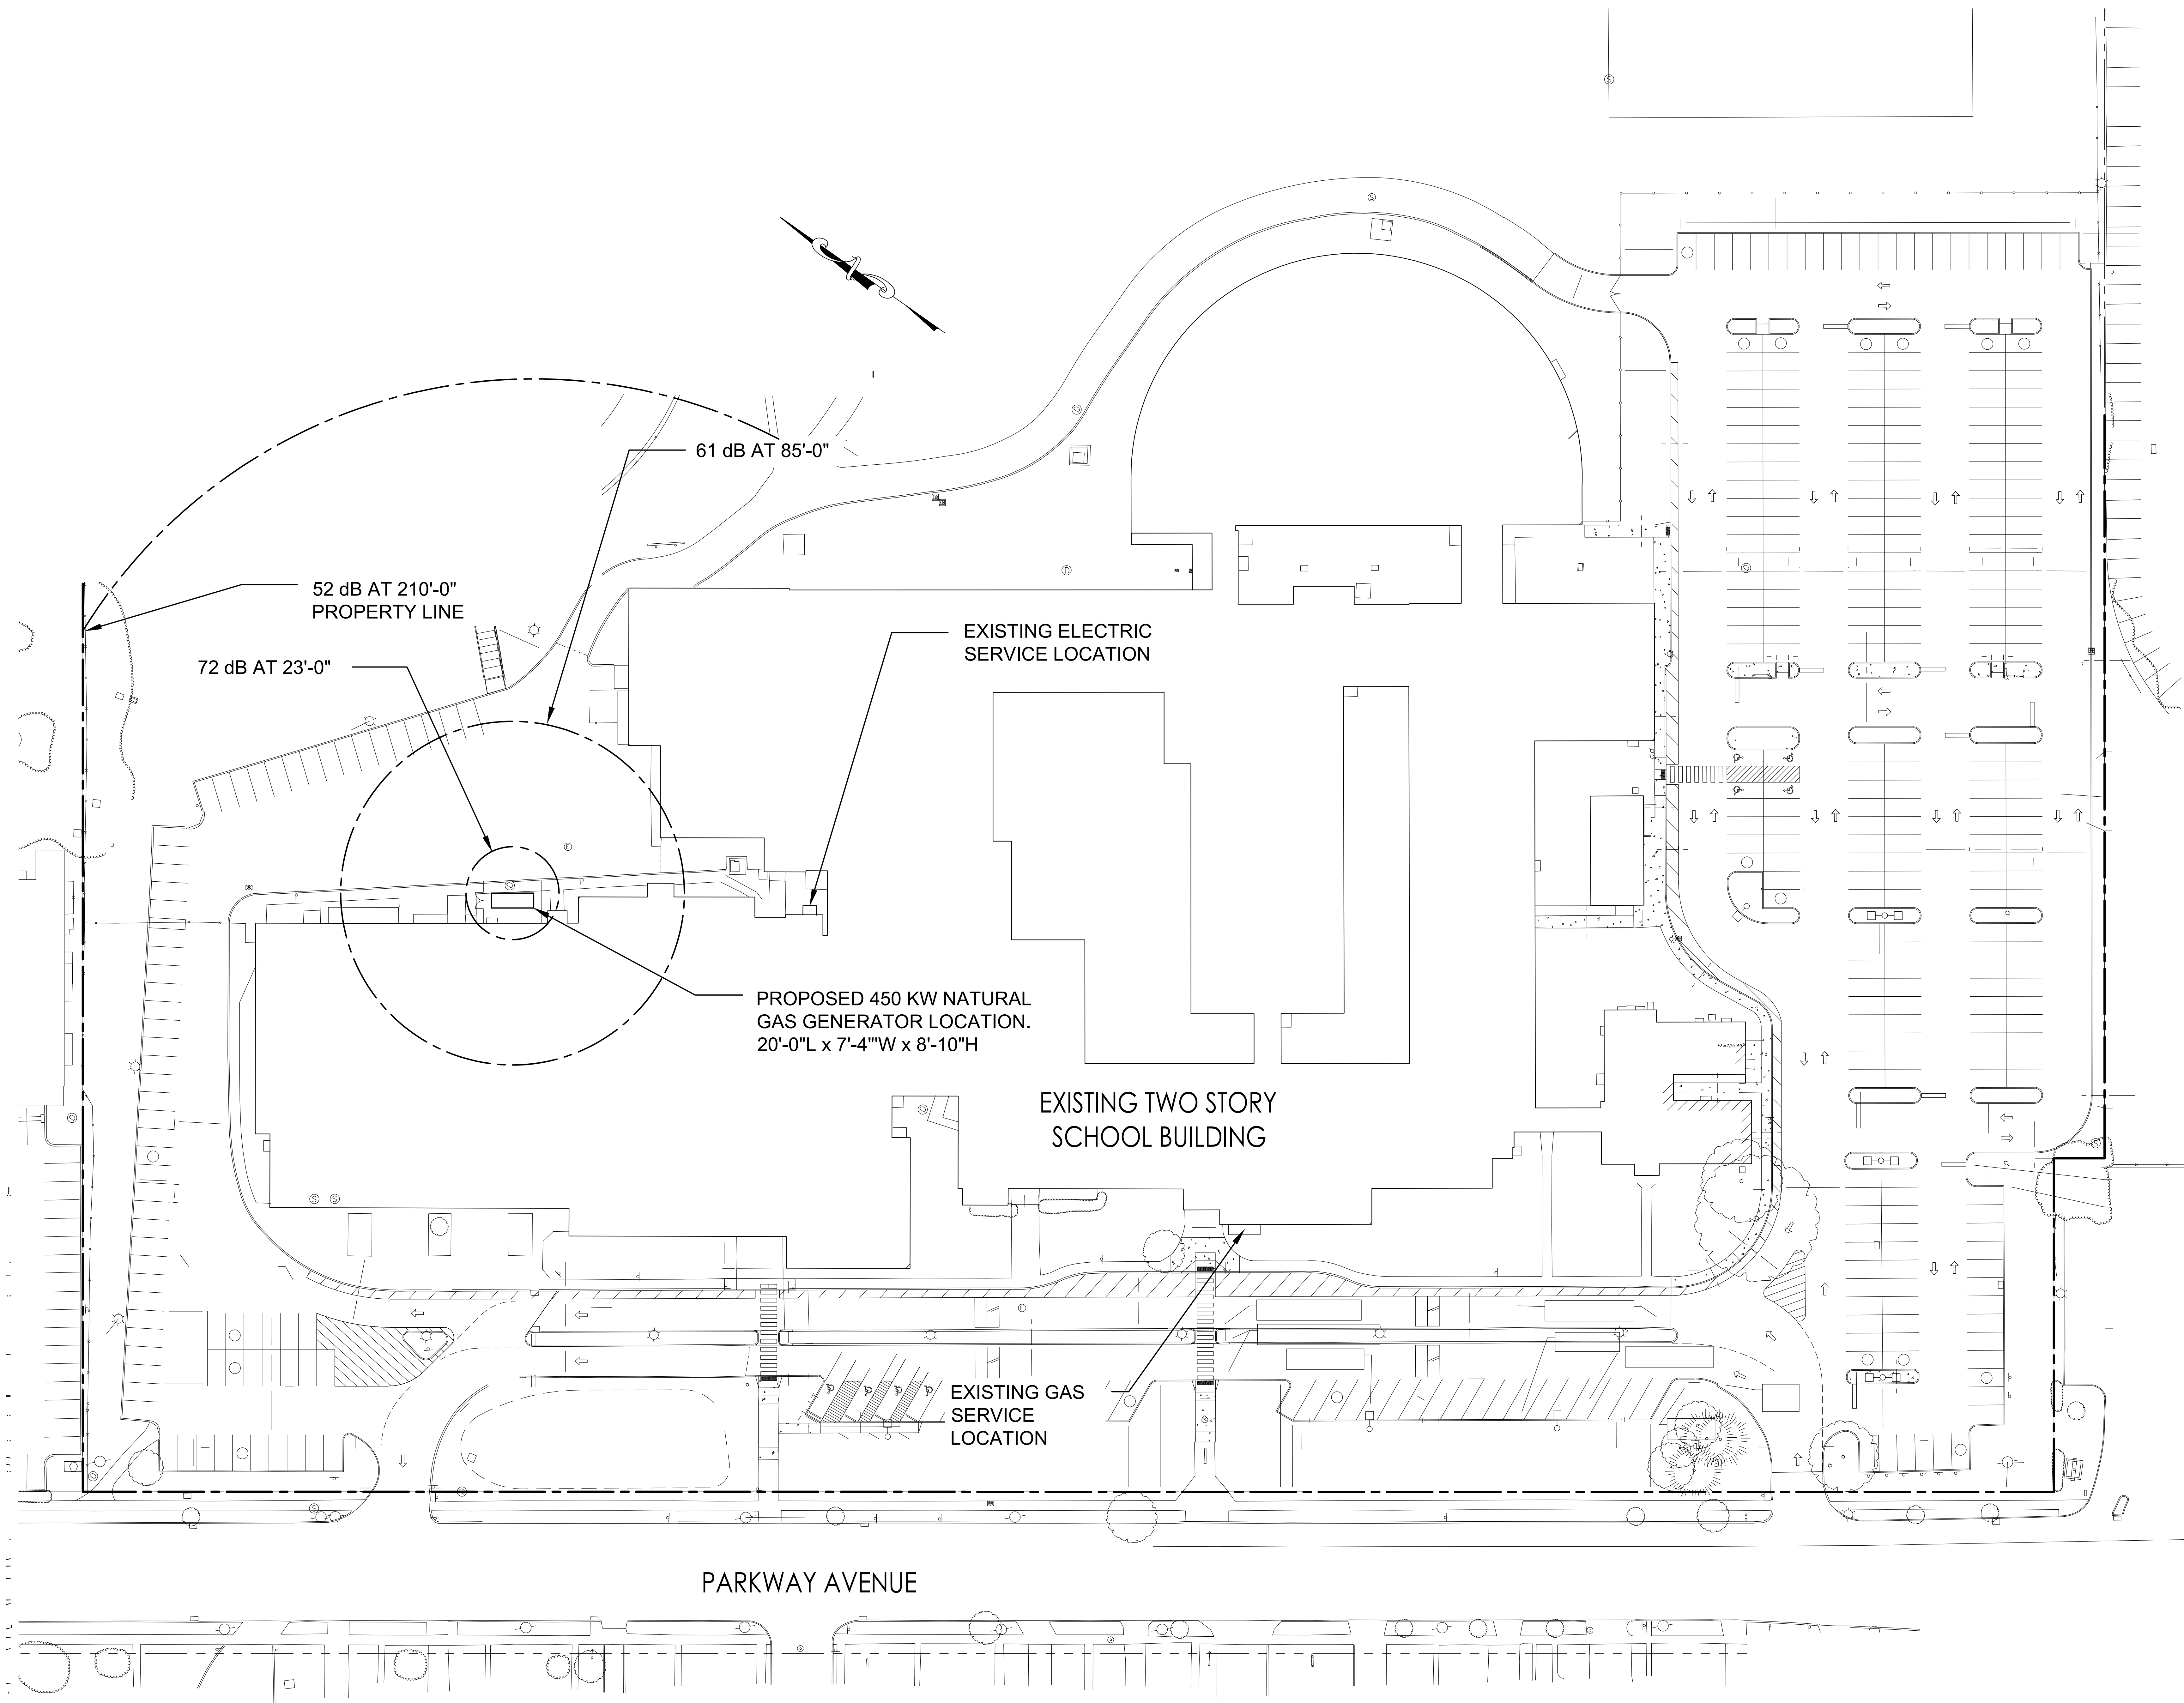

PARKWAY AVENUE

 **SITE PLAN**  
 SCALE: 1" = 30'-0"



COPYRIGHT 2019, FRENCH & PARRELLO ASSOCIATES, PA. THE COPYING OR REUSE OF THIS DOCUMENT, OR PORTIONS THEREOF, WITHOUT THE WRITTEN PERMISSION OF FRENCH & PARRELLO ASSOCIATES, PA IS PROHIBITED. DUE TO INHERENT ERRORS IN REPRODUCTION METHODS, ERRORS MAY OCCUR WHEN SCALING THIS DRAWING.